


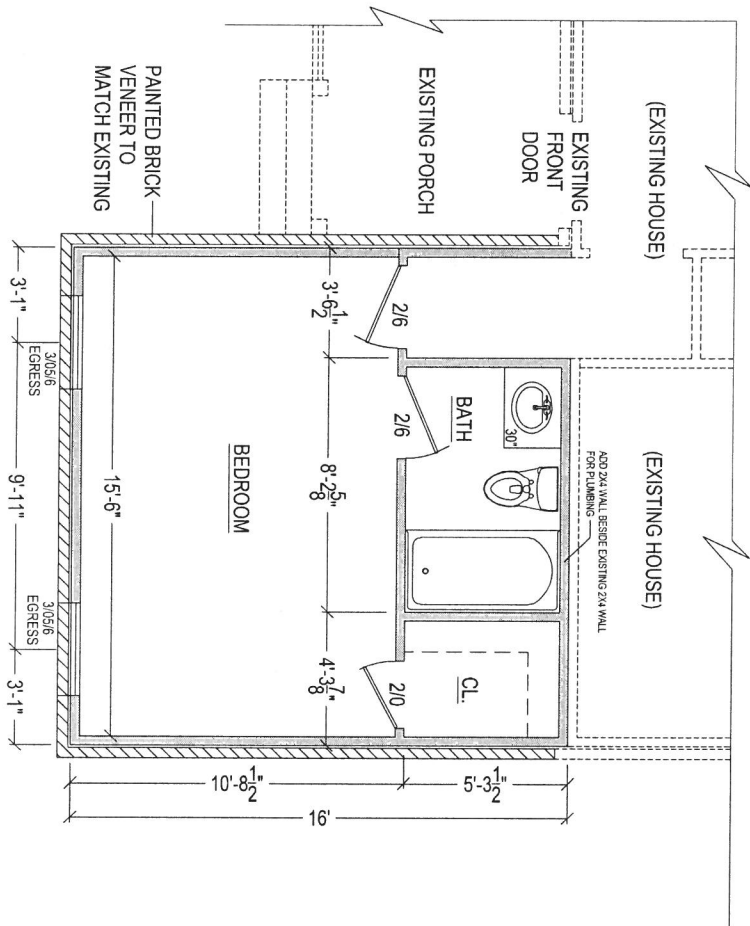

SCALE: 1/4" = 1'-0"

A101

DRAWN BY:
KEITH LARSON
712 ROBBIE NELLE DRIVE
HAHIRA, GEORGIA 31632
229-563-6589

DRAWING DATE: 3-20-2019

P.E. SEAL


RESIDENCE: Cal Patterson
Bedroom and Bath Addition
869 Wayland Ct SE
Smyrna, Ga 30080

DRAWING:

FLOOR PLAN

REVISION LOG	
DATE	DESCRIPTION

LDG
Larson Design Group

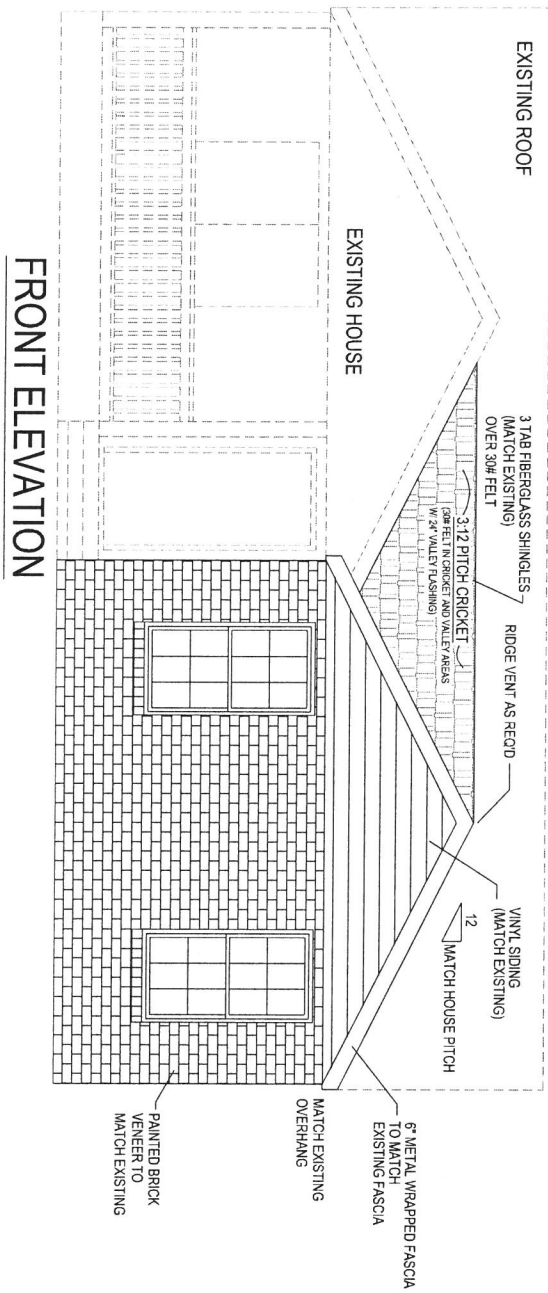

(REAR ELEVATION NOT APPLICABLE TO THE NEW ADDITION)

SCALE: 1/4" = 1'-0"

LDG
Larson Design Group

REVISION LOG	
DATE	DESCRIPTION

RESIDENCE: Cal Patterson
Bedroom and Bath Addition
869 Wayland Ct SE
Smyrna, Ga 30080



DRAWING:
FRONT ELEVATION

P.E. SEAL

DRAWN BY:
KEITH LARSON
712 ROBBIENELLE DRIVE
HAHIRA, GEORGIA 31632
229-563-6589

DRAWING DATE: 3-20-2019

A102

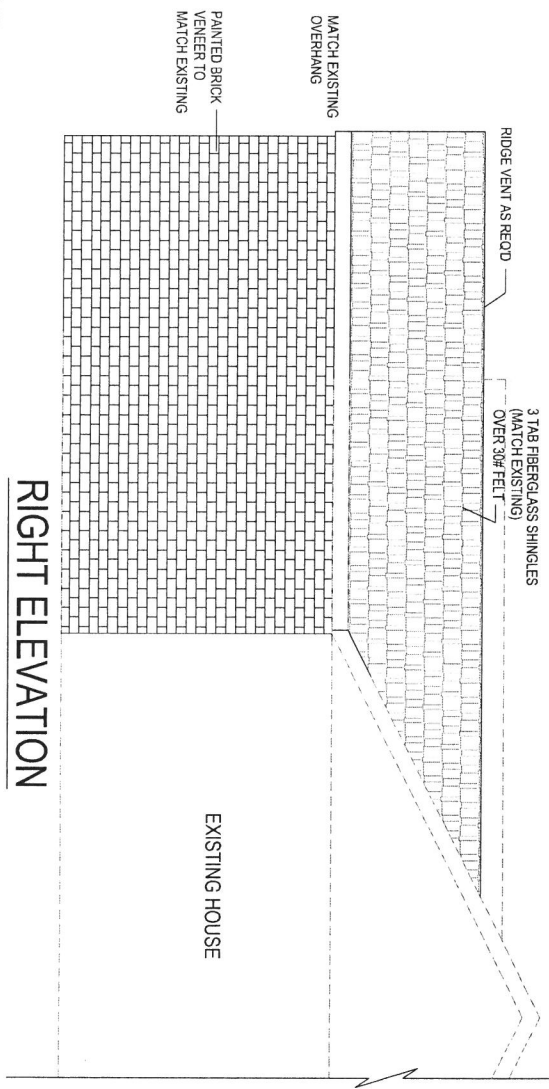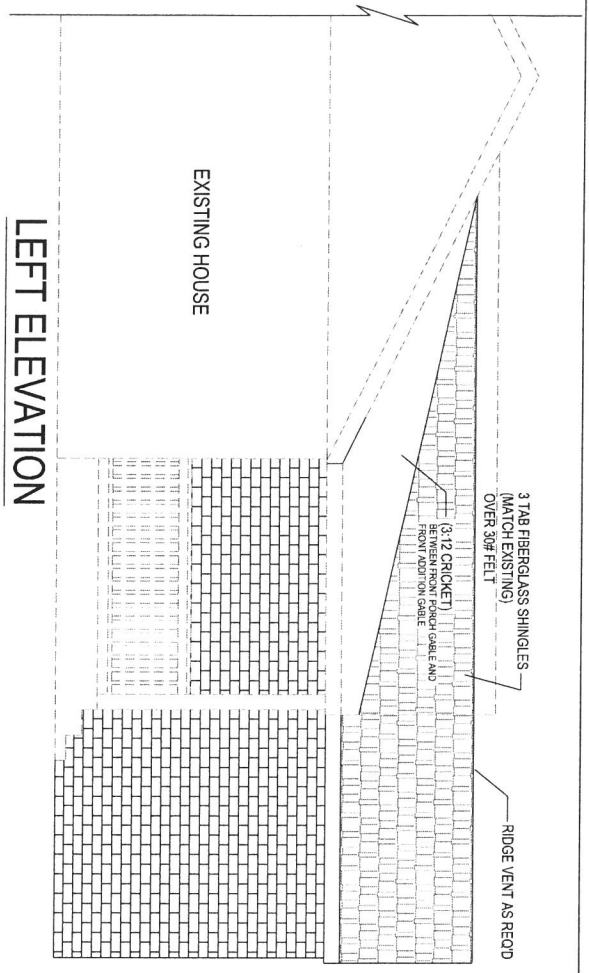

(REAR ELEVATION NOT APPLICABLE TO THIS ADDITION)

SCALE: 1/4" = 1'-0"

LDG
Larson Design Group

DATE	REVISION LOG
	DESCRIPTION

RESIDENCE: Cal Patterson
Bedroom and Bath Addition
869 Wayland Ct SE
Smyrna, Ga 30080

DRAWING:
RIGHT AND LEFT ELEVATIONS


P.E. SEAL

DRAWN BY:
KEITH LARSON
712 ROBBIE NELLE DRIVE
HAHIRA, GEORGIA 31632
229-563-6589

DRAWING DATE: 3-20-2019

A103

ELECTRICAL LEGEND	
SYMBOL	DESCRIPTION
\$	SWITCH
\$a	3-WAY SWITCH
⊖	120V DUPLEX RECEPTACLE
⊖	FLOOR RECEPT
⊖	240V RECEPTACLE
⊖	VANITY WALL MOUNT LIGHT
⊖	EXHAUST FAN
⊖	PENDANT LIGHT
○	RECESSED LIGHT
○	STANDARD LIGHT
⊖	WALL SCONCE
⊖	SMOKE DETECTOR
⊖	EXTERIOR WALL LIGHT
⊖	48" FLUORESCENT
⊖	FLOOD LIGHT
⊖	PHONE
⊖	TV
⊖	CEILING FAN

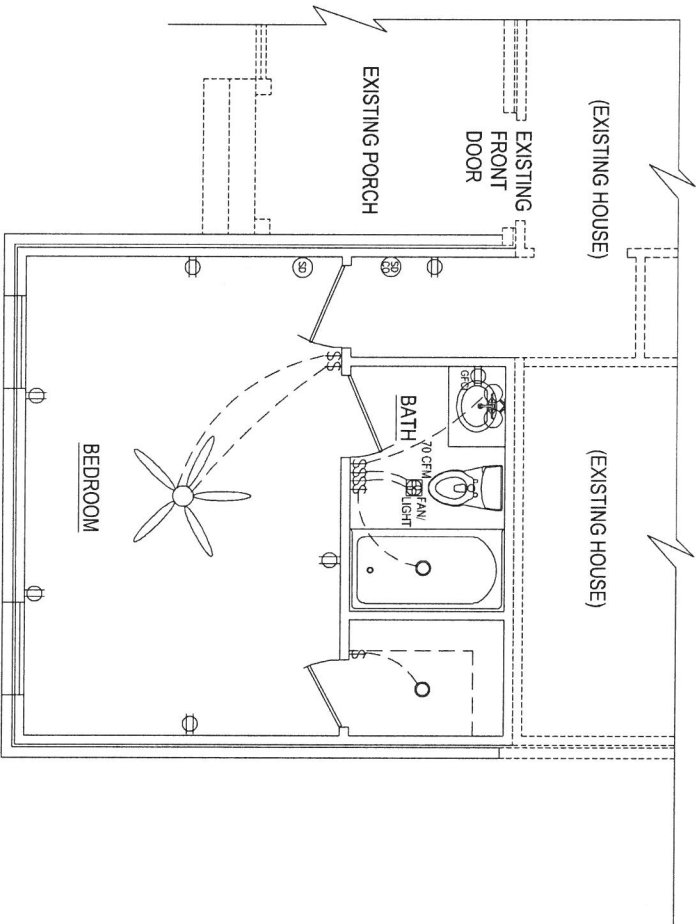

SCALE: 1/4" = 1'-0"

A104

DRAWN BY:
KEITH LARSON
712 ROBBIE NELLE DRIVE
HAHIRA, GEORGIA 31632
229-563-6589

DRAWING DATE: 3-20-2019

P.E. SEAL

RESIDENCE: Cal Patterson
Bedroom and Bath Addition
869 Wayland Ct SE
Smyrna, Ga 30080

DRAWING:
ELECTRICAL PLAN

REVISION LOG	
DATE	DESCRIPTION

LDG
Larson Design Group



DRAWING DATE: 3-20-2019

P.E. SEAL

RESIDENCE: Cal Patterson
Bedroom and Bath Addition
869 Wayland Ct SE
Smyrna, Ga 30080

DRAWING:

WALL SECTION

[illegible]

LDG
Larson Design Group



**MATCH ROOF PITCH
TO EXISTING HOUSE**

RUN 2X6 CLG JOISTS
PERPENDICULAR TO
ROOF RAFTERS AND BEAR
OVER BATH/BEDROOM WALL

SCALE: 1/4" = 1'-0"

A106

DRAWN BY:
KEITH LARSON
712 ROBBIENELLE DRIVE
HAHIRA, GEORGIA 31632
229-563-6589

DRAWING DATE: 3-20-2019

P.E. SEAL


RESIDENCE: Cal Patterson
Bedroom and Bath Addition
869 Wayland Ct SE
Smyrna, Ga 30080

DRAWING:

ROOF FRAMING PLAN

[illegible]

LDG
Larson Design Group

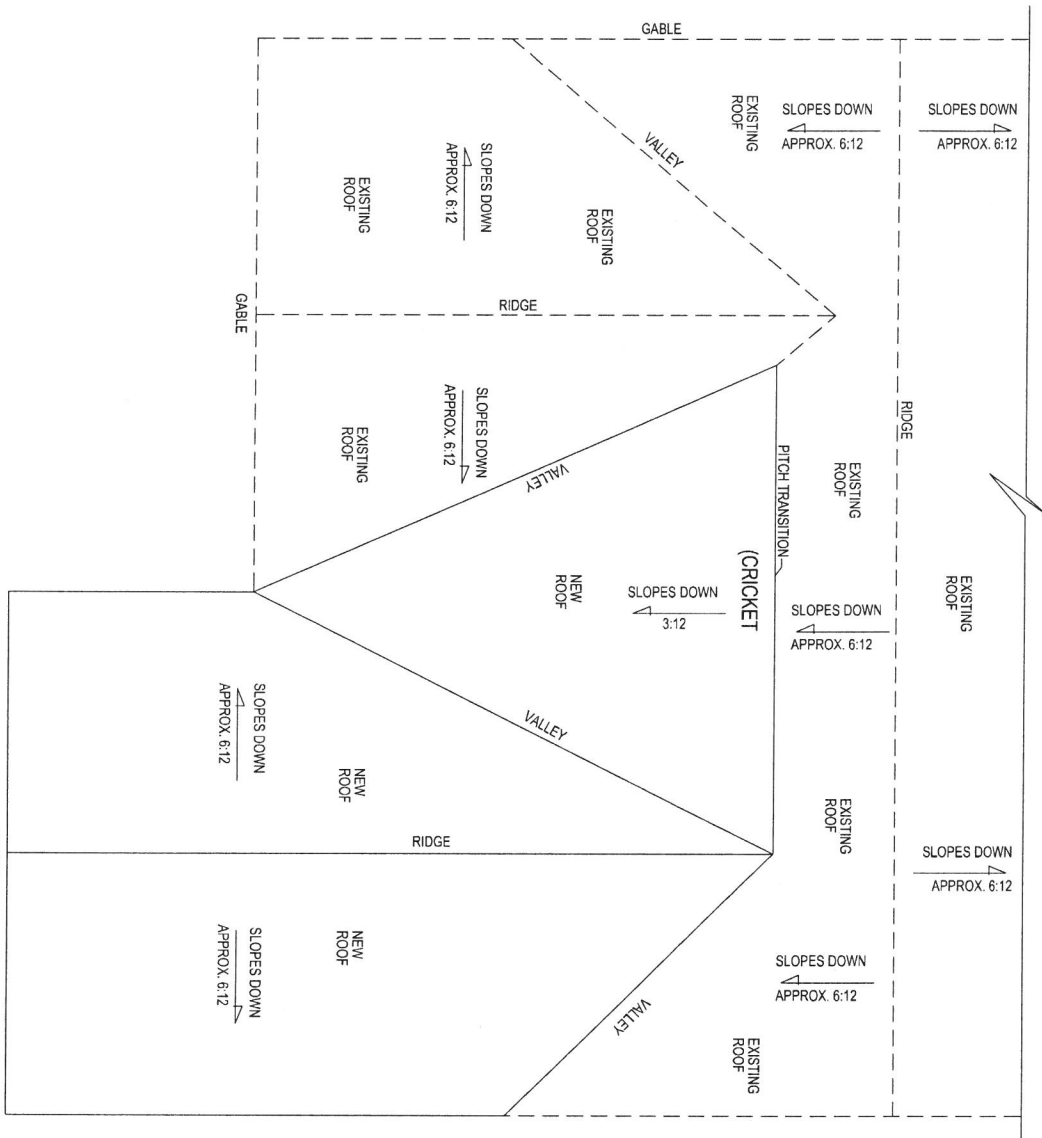

SCALE: 1/4" = 1'-0"

A107

DRAWN BY:
KEITH LARSON
712 ROBBIE NELLE DRIVE
HAHIRA, GEORGIA 31632
229-563-6589

DRAWING DATE: 3-20-2019


P.E. SEAL

RESIDENCE: Cal Patterson
Bedroom and Bath Addition
869 Wayland Ct SE
Smyrna, Ga 30080

DRAWING:
ROOF PLAN

REVISION LOG	
DATE	DESCRIPTION

LDG
Larson Design Group

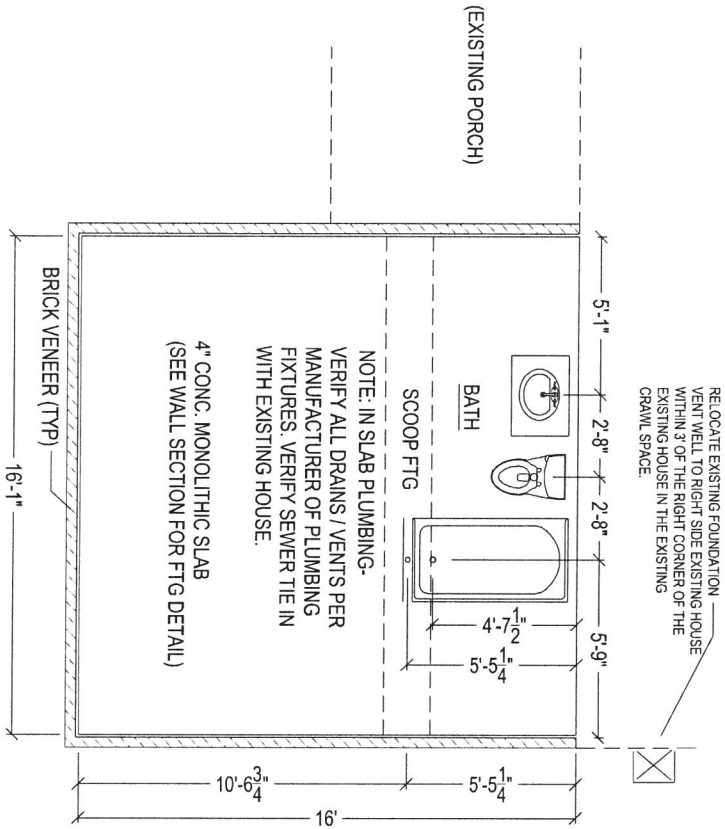

SCALE: 1/4" = 1'-0"

A108

DRAWN BY:
KEITH LARSON
712 ROBBIE NELLE DRIVE
HAHIRA, GEORGIA 31632
229-563-6589

DRAWING DATE: 3-20-2019

P.E. SEAL

RESIDENCE: Cal Patterson
Bedroom and Bath Addition
869 Wayland Ct SE
Smyrna, Ga 30080

DRAWING:
FOUNDATION

REVISION LOG	
DATE	DESCRIPTION

LDG
Larson Design Group